

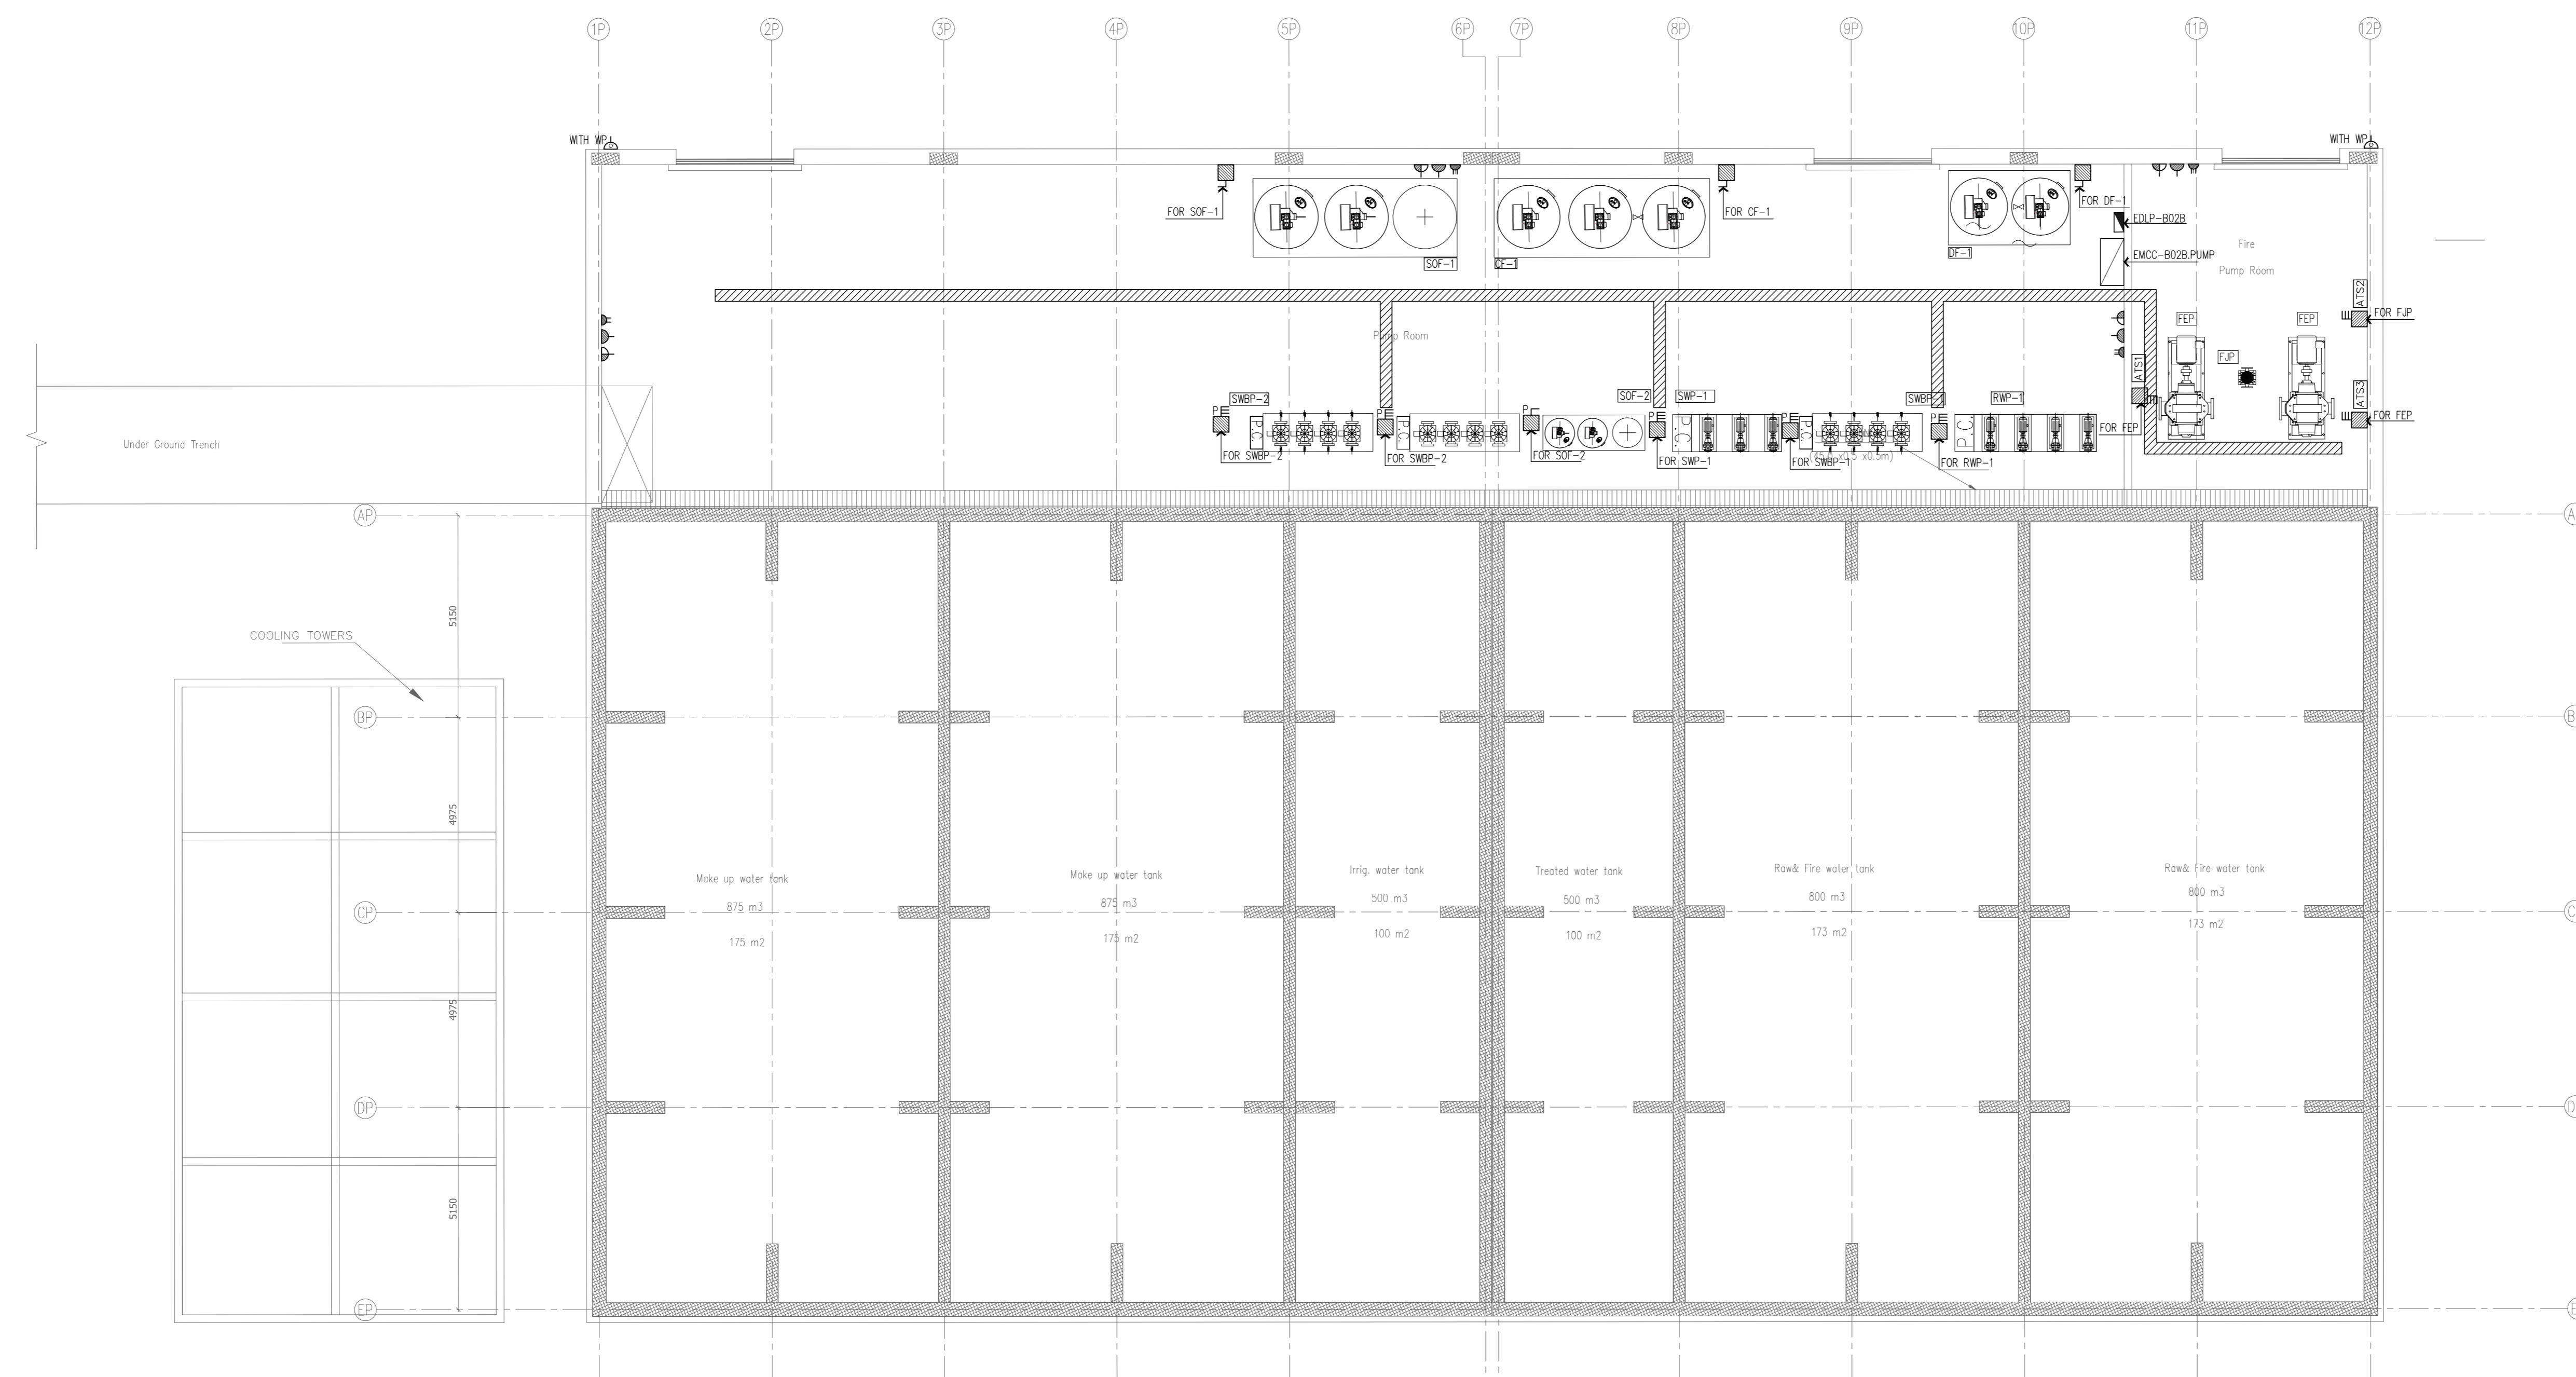


① GROUND FLOOR LIGHTING LAYOUT  
SCALE: 1:100

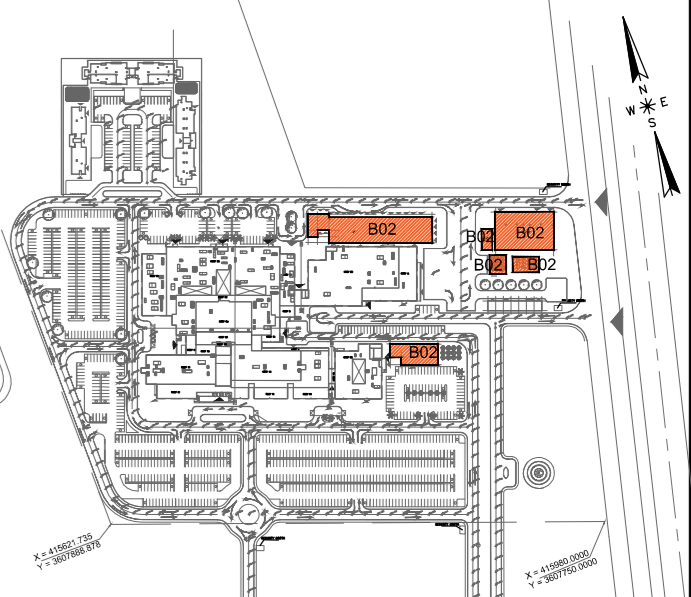

② GROUND FLOOR POWER LAYOUT  
SCALE: 1:100

General Notes :

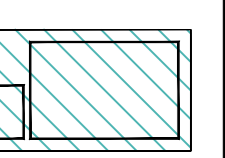

MINISTRY OF HIGHER EDUCATION  
AND SCIENTIFIC RESEARCH  
University Of Karbala



PROJECT MANAGEMENT CONSULTANT  
**AM TECH**

MAIN CONTRACTOR  
**FOURTH DIMENSION**  
Generating Engineering & Construction  
**C.B.C**

PRINCIPAL ENGINEERING CONSULTANT  
**ARABTECH JARDANEH**

CONSULTING HEALTH PLANNERS  
**HDP** healthcare designers  
and project managers

CONSULTING INTERNATIONAL ARCHITECTS  
**LEO A DALY** PLANNING ARCHITECTURE ENGINEERING INTERIORS

THIS DRAWING IS THE  
COPYRIGHT OF ARABTECH  
JARDANEH ENGINEERS &  
ARCHITECTS AND MUST NOT BE  
REPRODUCED, COPIED OR USED  
WITHOUT THE CONSULTANTS  
AUTHORIZATION

REV.	DESCRIPTION	APPRO. BY	DATE


DRAWN BY: E.D. DESIGNED BY: A.D.  
CHECKED BY: M.M.H. APPROVED BY: F.J.  
QC REVIEW BY: DWG ISSUE DATE: 26.10.2014

PROJECT:  
**KARBALA 600 BED TEACHING  
UNIVERSITY HOSPITAL, IRAQ**


CONCEPT DESIGN STAGE PRELIMINARY DESIGN STAGE  
DESIGN DEVELOPMENT STAGE CONSTRUCTION DRAWINGS STAGE

DRAWING TITLE:  
**BLOCK-02b ANCILLARY BUILDING  
GROUND FLOOR PLAN  
LIGHTING LAYOUT &  
POWER LAYOUT**

NO. 01586 DWG. KH-EW-101 BLOCK B2b  
1:100 @ (A0) SHE. 01 OF 01 REV. RO


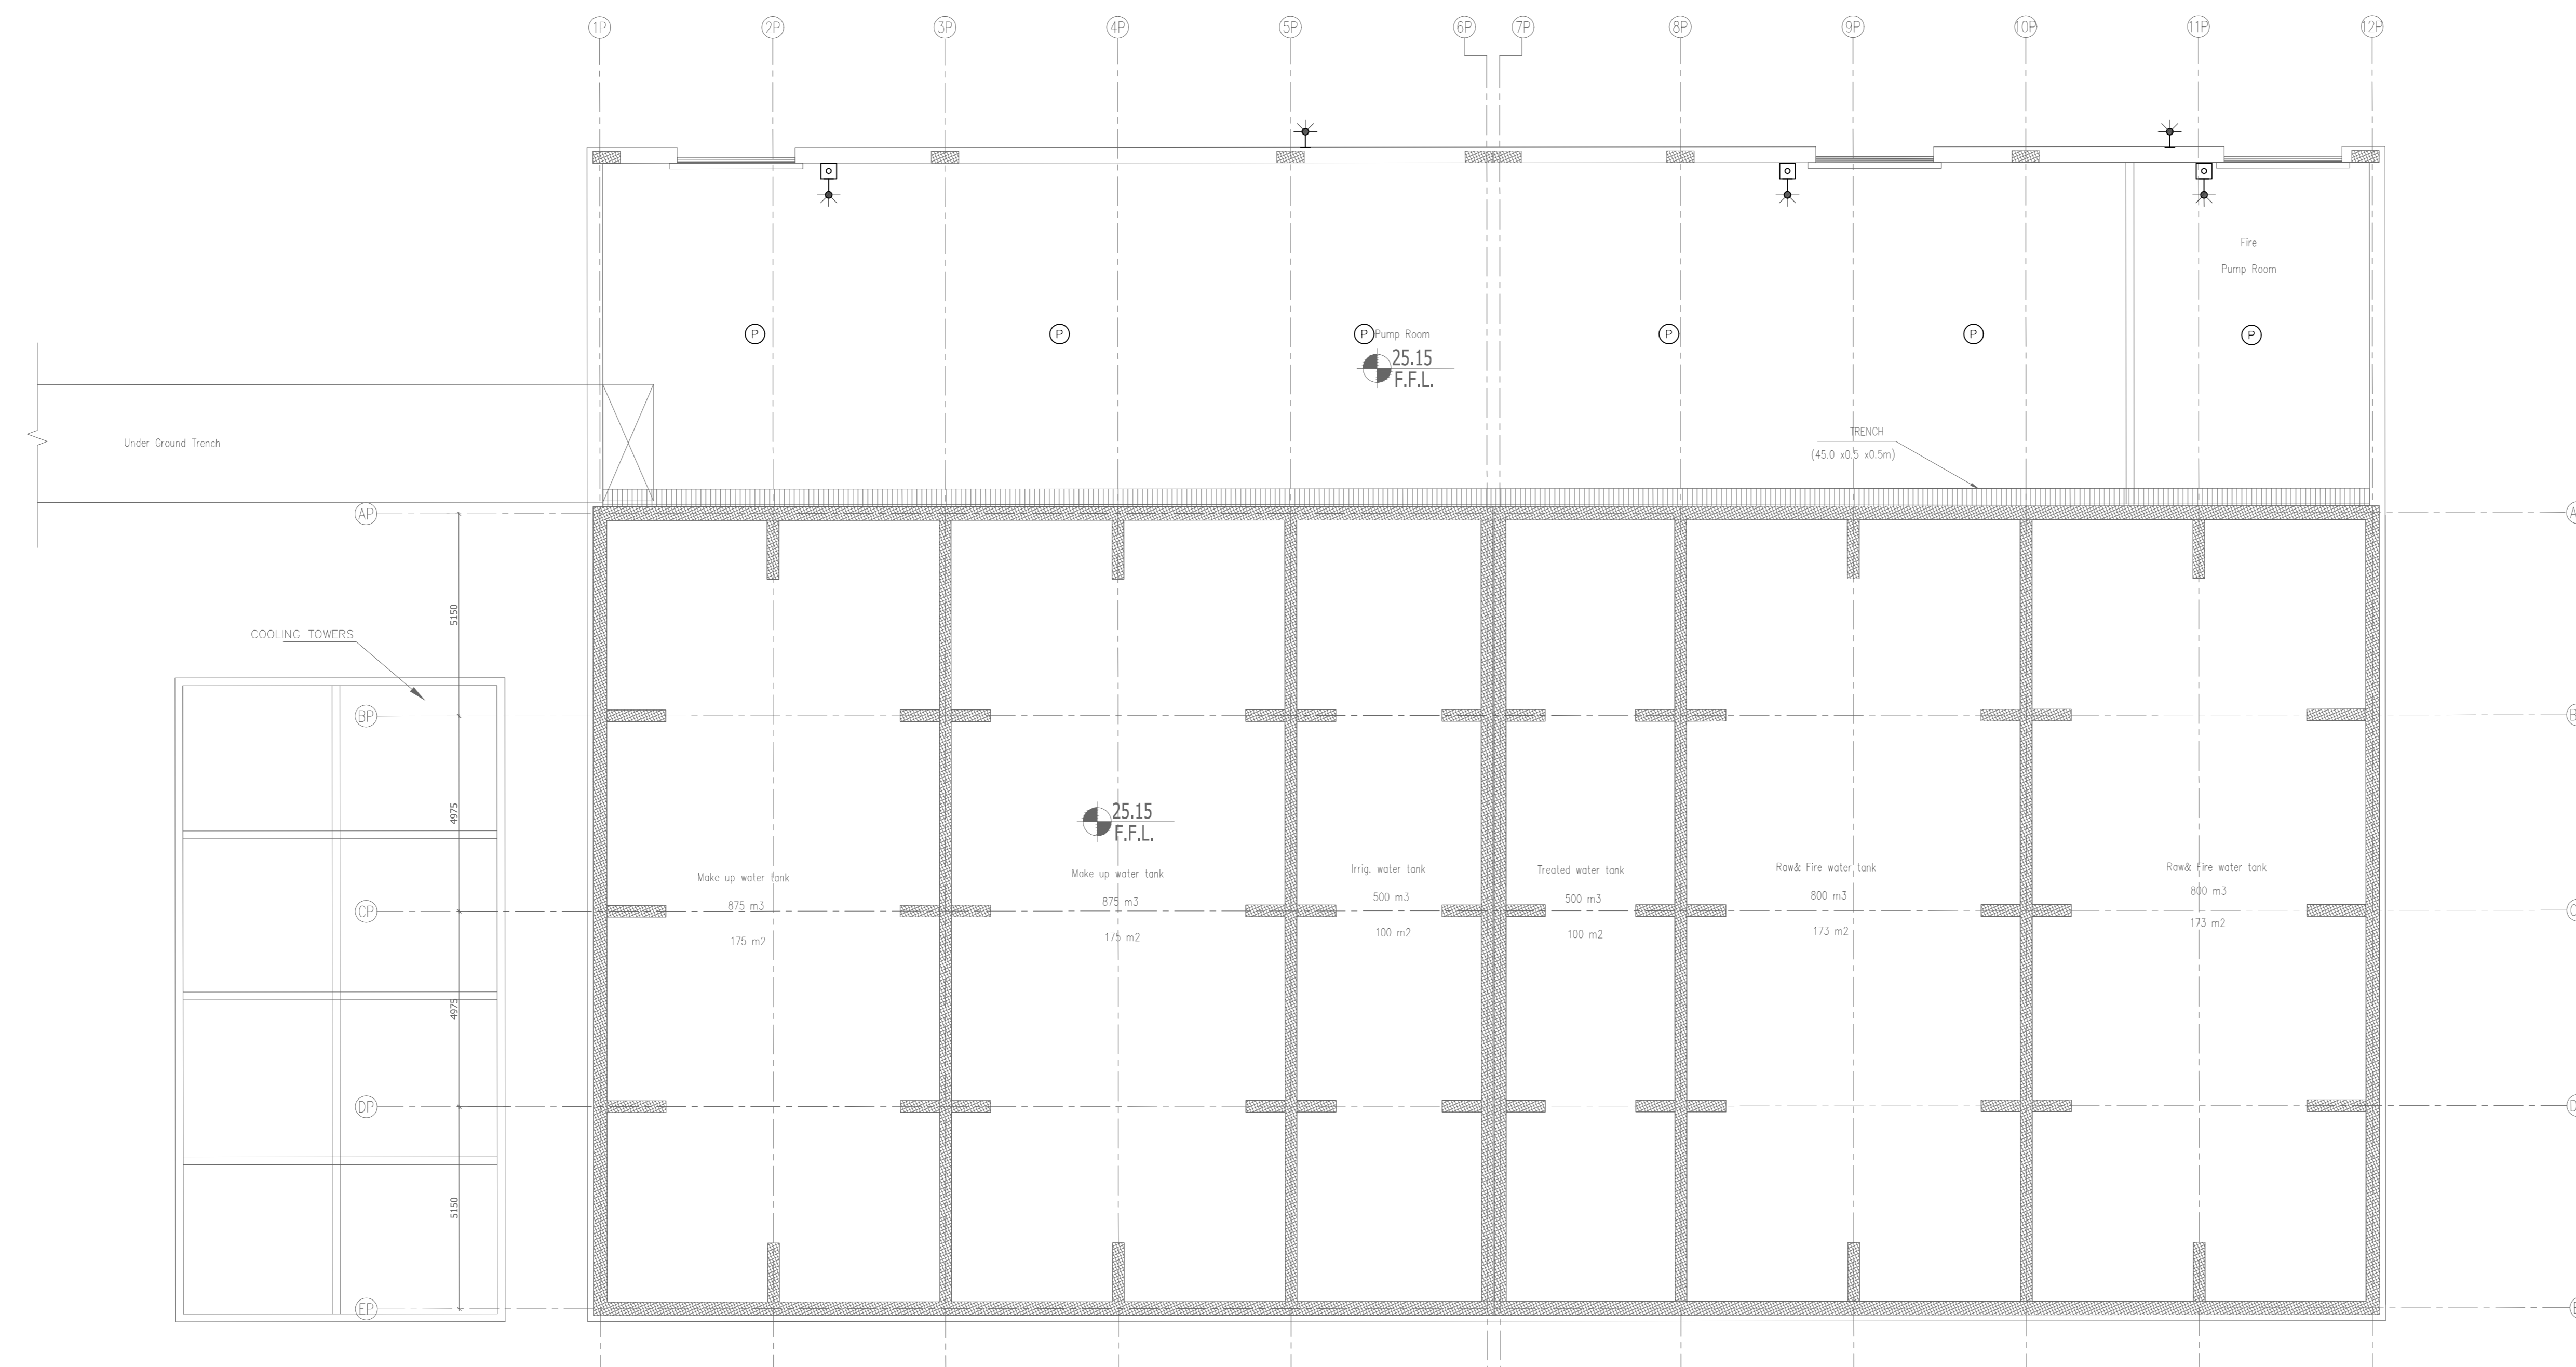


1 GROUND FLOOR FIRE ALARM SYSTEM  
SCALE: 1:100

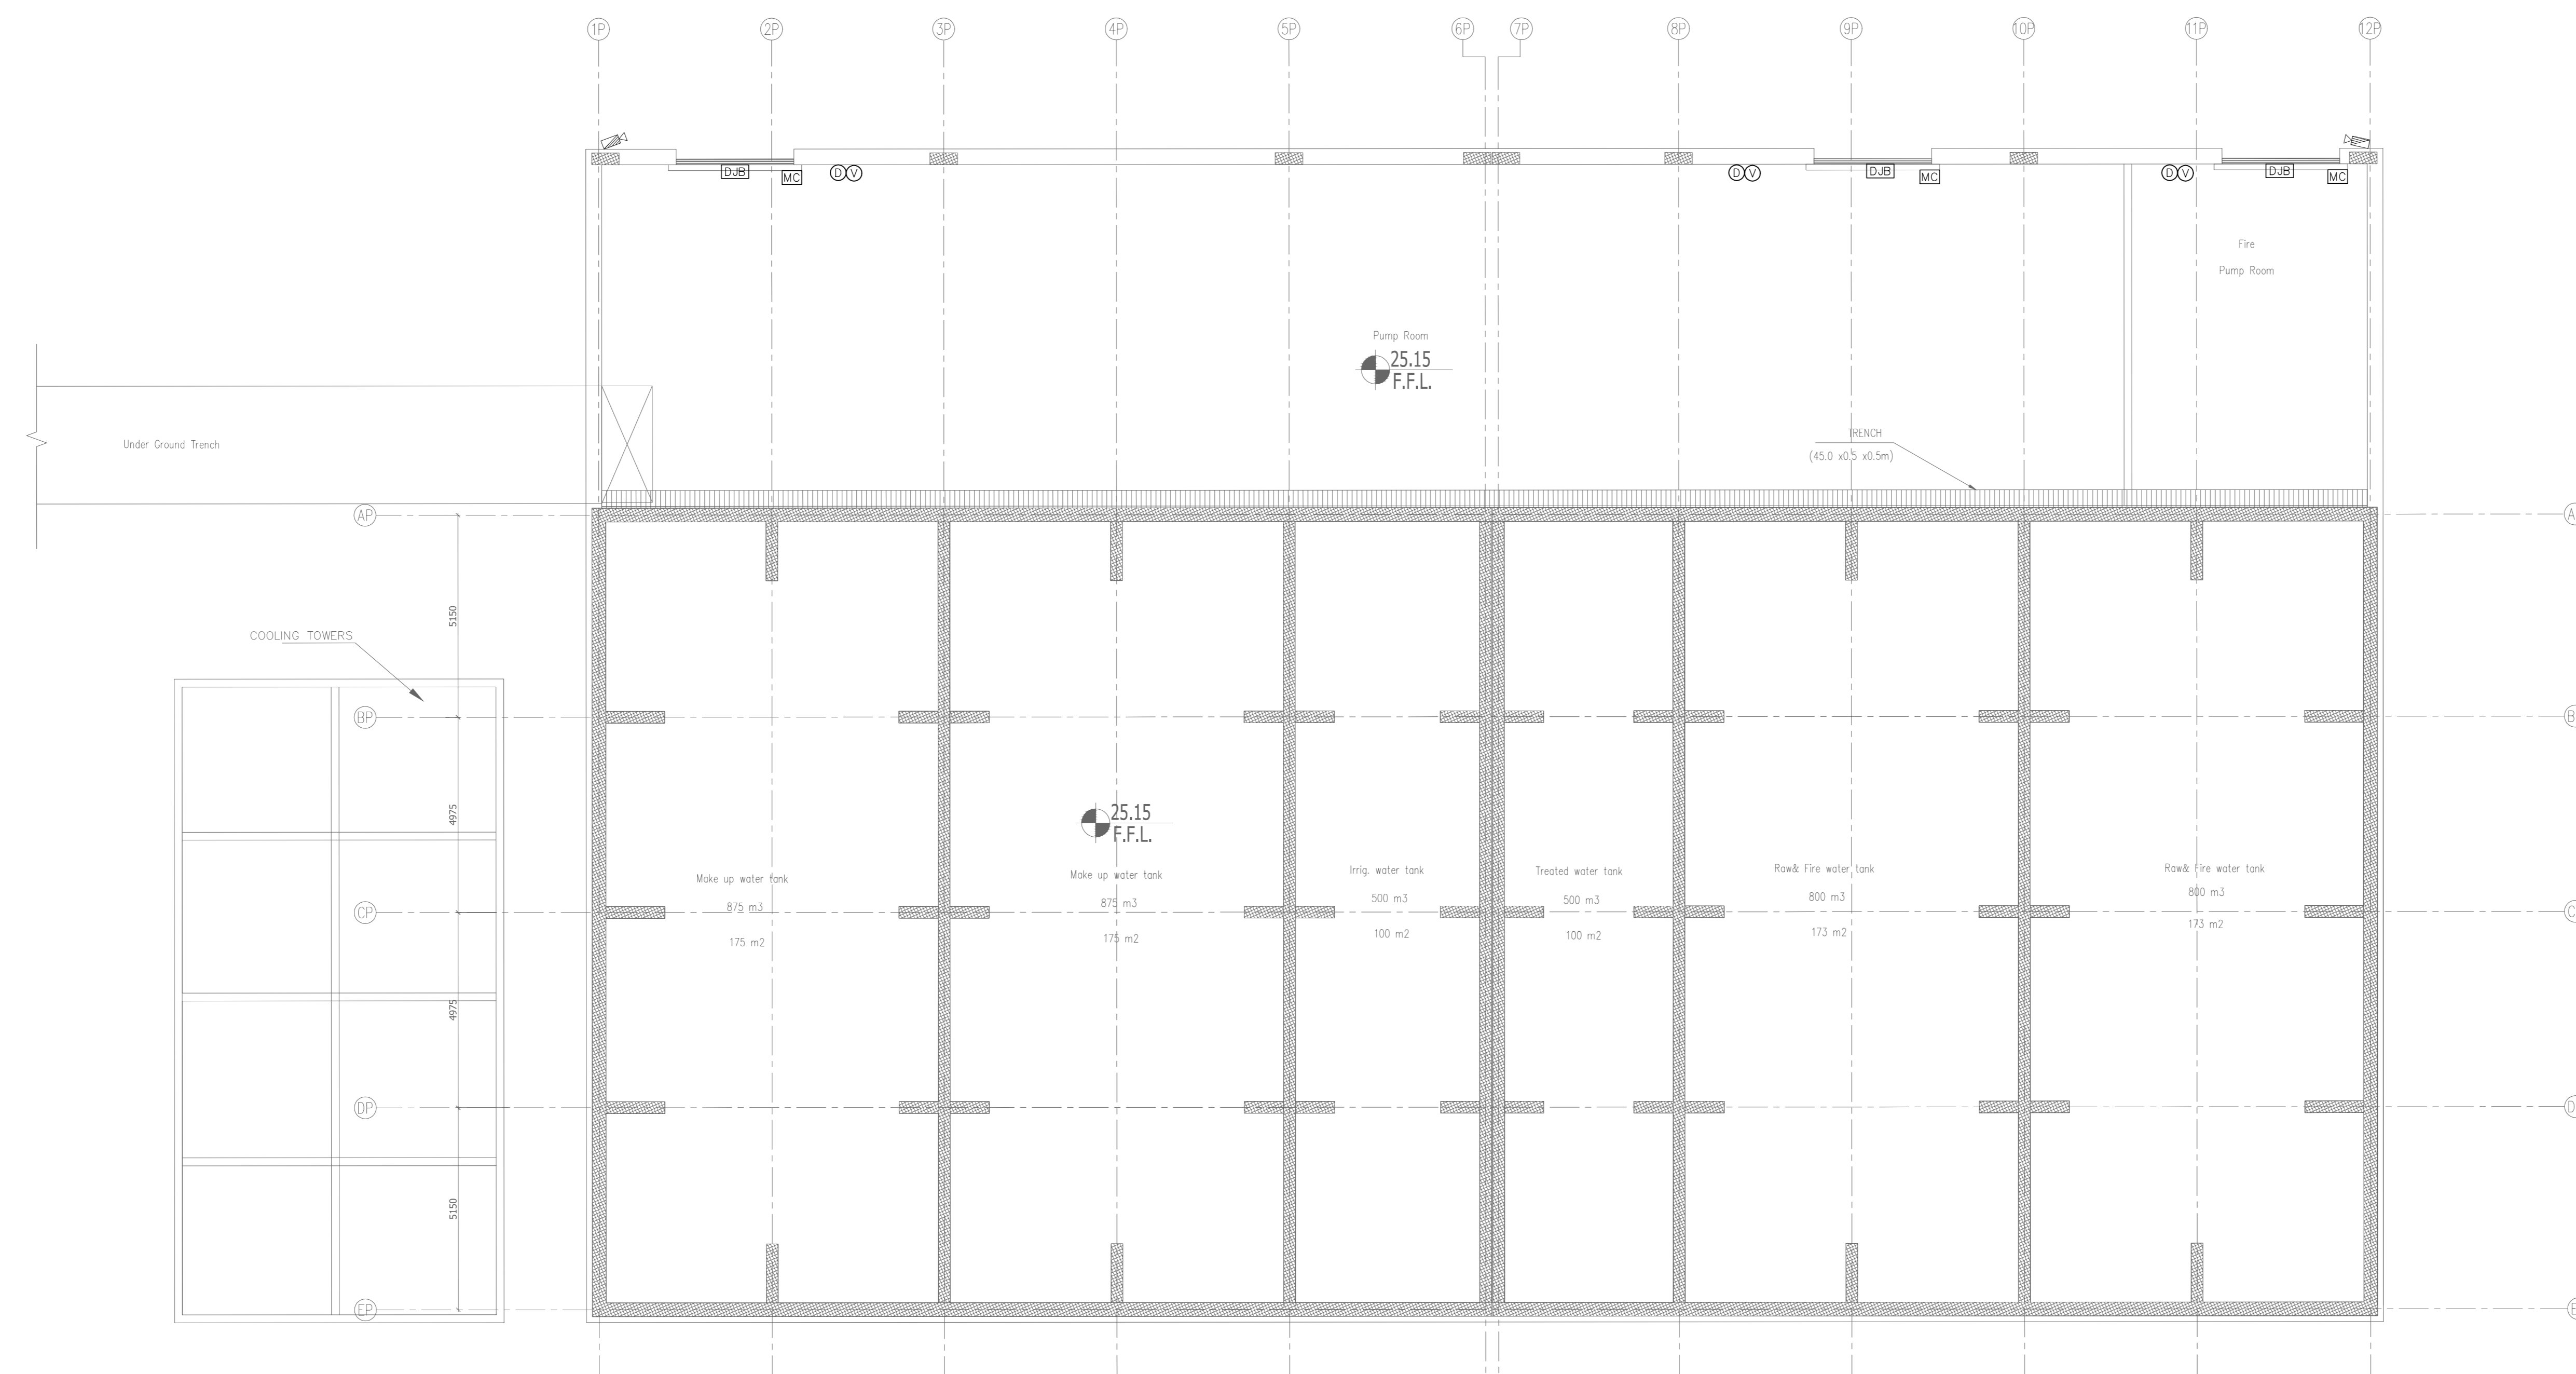

2 GROUND FLOOR IT SYSTEM  
SCALE: 1:100

General Notes :

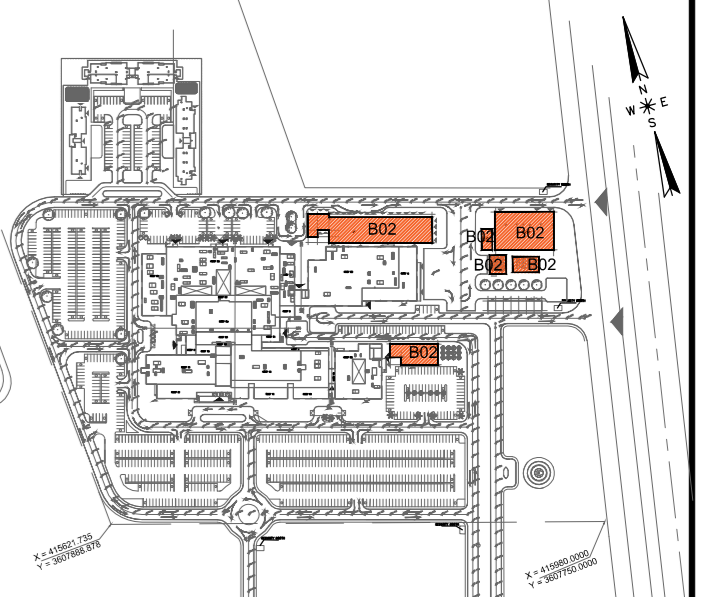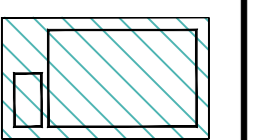

MINISTRY OF HIGHER EDUCATION AND SCIENTIFIC RESEARCH  
University Of Karbala



PROJECT MANAGEMENT CONSULTANT:  
**AM TECH**

MAIN CONTRACTOR:  
**FOURTH DIMENSION**  
General Engineering & Construction  
**C.B.C**

PRINCIPAL ENGINEERING CONSULTANT:  
**ARABTECH JARDANEH**

CONSULTING HEALTH PLANNERS:  
**HDP** healthcare designers  
and project managers

CONSULTING INTERNATIONAL ARCHITECTS:  
**LEO A DALY** PLANNING ARCHITECTURE ENGINEERING INTERIORS

THIS DRAWING IS THE  
COPYRIGHT OF ARABTECH  
JARDANEH ENGINEERS &  
ARCHITECTS AND MUST NOT BE  
REPRODUCED, COPIED OR USED  
WITHOUT THE CONSULTANTS  
AUTHORIZATION

REV.	DESCRIPTION	APPRO. BY	DATE

DRAWN BY: E.D. DESIGNED BY: A.D.  
CHECKED BY: M.M.H. APPROVED BY: F.J.  
QC REVIEW BY: DWG ISSUE DATE: 26.10.2014



PROJECT:  
**KARBALA 600 BED TEACHING UNIVERSITY HOSPITAL, IRAQ**

CONCEPT DESIGN STAGE	PRELIMINARY DESIGN STAGE
DESIGN DEVELOPMENT STAGE	CONSTRUCTION DRAWINGS STAGE

DRAWING TITLE:  
**BLOCK-02b ANCILLARY BUILDING  
GROUND FLOOR PLAN  
FIRE ALARM SYSTEM &  
IT SYSTEM**

NO. 01586 DWG. KUHEW-102 BLOCK B2b  
1:100 @ (A0) SHE. 01 OF 01 REV. RO

General Notes :

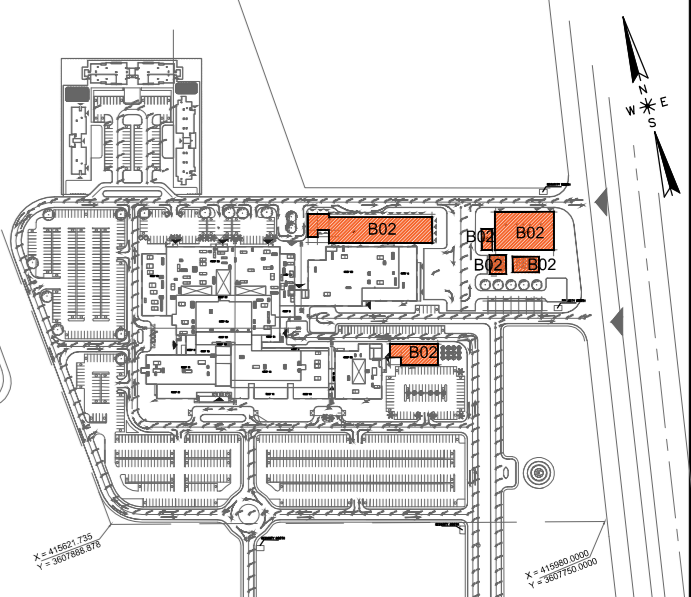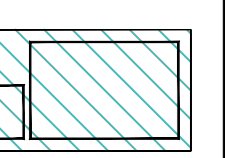

MINISTRY OF HIGHER EDUCATION AND SCIENTIFIC RESEARCH  
University Of Karbala



PROJECT MANAGEMENT CONSULTANT:  
**AM TECH**

MAIN CONTRACTOR:  
**FOURTH DIMENSION**  
Consulting Engineering & Construction  
**C/S.C**

PRINCIPAL ENGINEERING CONSULTANT:  
**ARABTECH JARDANEH**

CONSULTING HEALTH PLANNERS:  
**HDP** healthcare designers  
and project managers

CONSULTING INTERNATIONAL ARCHITECTS:  
**LEO A DALY** PLANNING ARCHITECTURE ENGINEERING INTERIORS

THIS DRAWING IS THE  
COPYRIGHT OF ARABTECH  
JARDANEH ENGINEERS &  
ARCHITECTS AND MUST NOT BE  
REPRODUCED, COPIED OR USED  
WITHOUT THE CONSULTANTS  
AUTHORIZATION

REV.	DESCRIPTION	APPRO. BY	DATE


DRAWN BY: E.D. DESIGNED BY: A.D.  
CHECKED BY: M.M.H. APPROVED BY: F.J.  
QC REVIEW BY: DWG ISSUE DATE: 26.10.2014

PROJECT:  
**KARBALA 600 BED TEACHING UNIVERSITY HOSPITAL, IRAQ**

CONCEPT DESIGN STAGE	PRELIMINARY DESIGN STAGE
DESIGN DEVELOPMENT STAGE	CONSTRUCTION DRAWINGS STAGE

DRAWING TITLE:  
**BLOCK-02b ANCILLARY BUILDING  
GROUND FLOOR PLAN  
EARTHING & GROUNDING SYSTEM**

AB # **01586** DWG: **KUH-EW-103** BLOCK # **B2b**  
1:100 @ (A0) Sta. 01 of 01 REV # **RO**

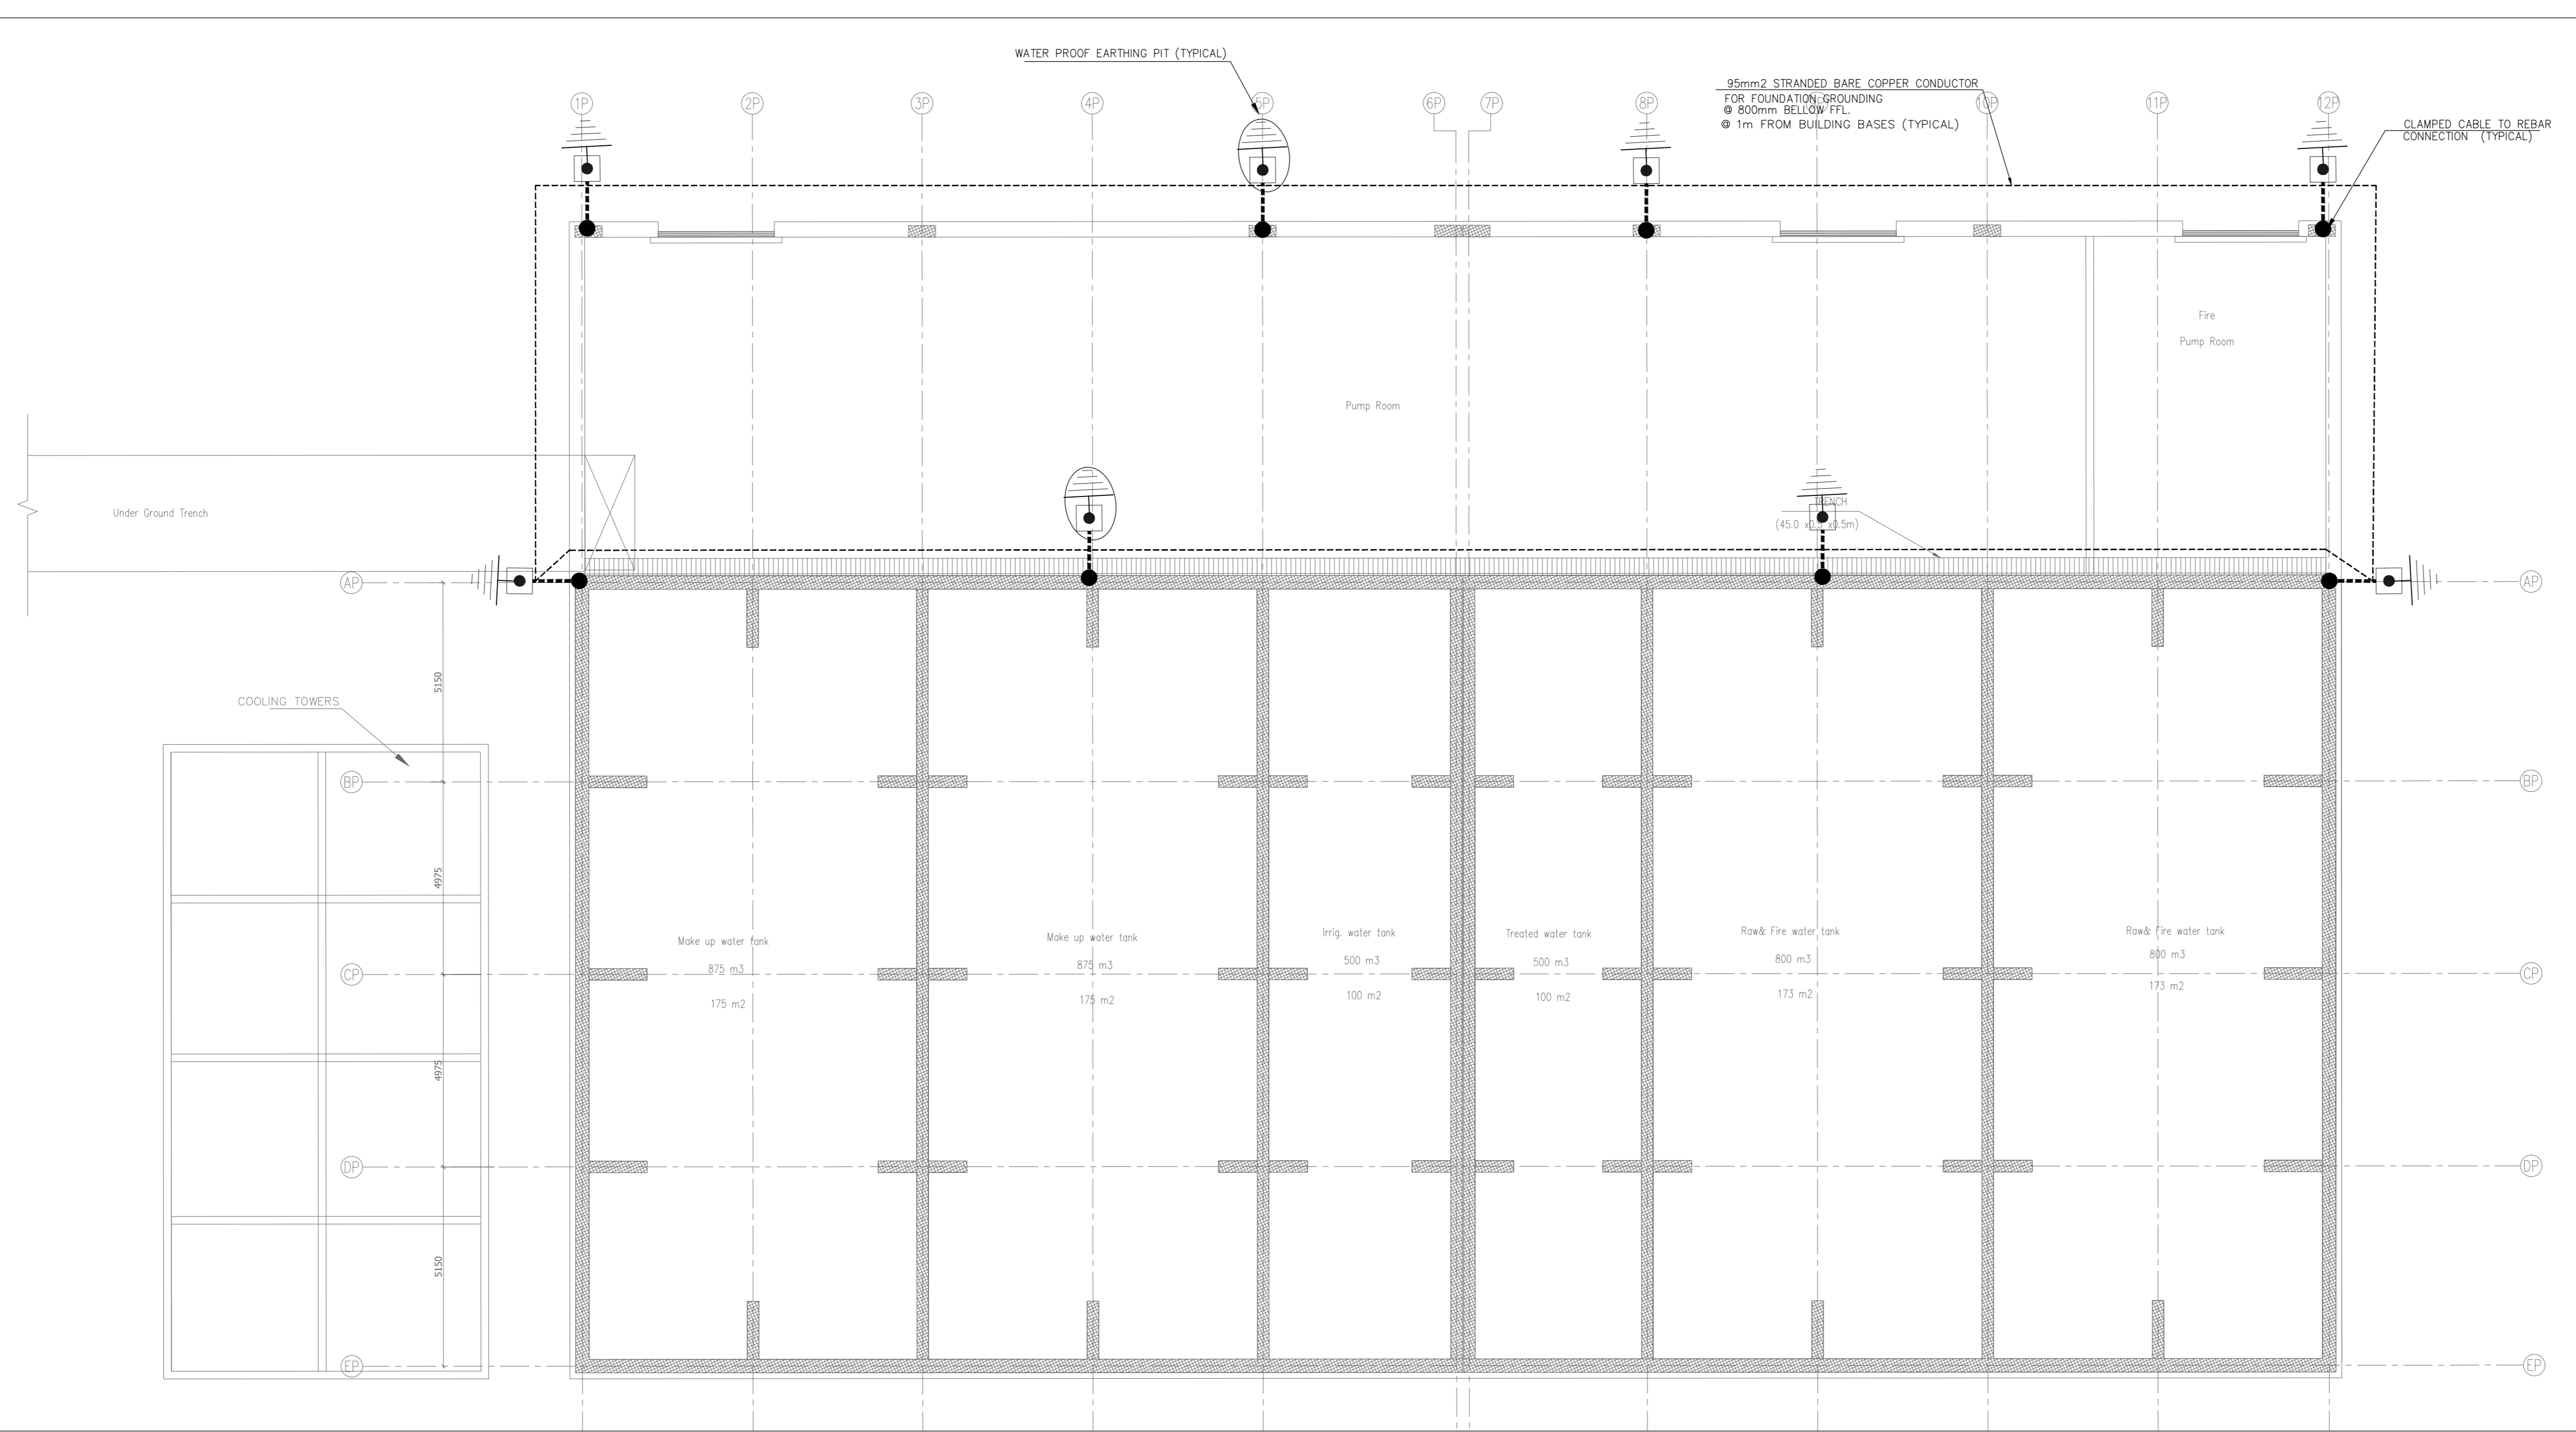

1 GROUND FLOOR EARTHING & GROUNDING SYSTEM  
SCALE: 1:100